



मदन मोहन मालवीय प्रौद्योगिकी विश्वविद्यालय

गोरखपुर – 273 010 (उ.प्र.) भारत

उ.प्र. सरकार के अधिनियम संख्या 22/2013 द्वारा स्थापित (पूर्ववर्ती मदन मोहन मालवीय इंजीनियरिंग कालेज, गोरखपुर | स्थापित-1962)

Madan Mohan Malaviya University of Technology

Gorakhpur – 273 010 (U.P.) India

Established by Act. No. 22 of 2013 of U.P. Govt. (Formerly Madan Mohan Malaviya Engineering College, Gorakhpur | Estd. 1962)



चन्द्र प्रकाश प्रियदर्शी

कुलसचिव

Chandra Prakash Priyadarshi
Registrar

No. MUT/ Kus. Ka./ 350 / 2025

 
Dated: 29, January, 2025

TO WHOME SO EVER IT MAY CONCERN

This is to certify that the Madan Mohan Malaviya University of Technology, Gorakhpur has been established by the Govt. of Uttar Pradesh vide UP Act No. 22 of 2013 passed by the Uttar Pradesh Legislature. All academic/residential buildings of the campus are constructed by the Govt. nominated agencies in accordance with the extant Govt. rules and regulations. It is further certified that in terms of the existing regulations, the University is not supposed to seek approval from the local authorities for building plan, layout plan, building completion certificate etc. from the local authorities. Relevant details of the building proposed to be used for the ITEP Programme is as below: -



Total Land Area:	1350 Sqm.
Total Built up Area:	2494 Sqm. (GF 1350 Sqm. + FF 1144 Sqm.)
Multipurpose Hall Area:	1020 Sqm.
Library cum Reading Room:	250.37 Sqm.
Name and Address of Construction Agency (nominated by the Govt. of UP):	UP State Construction and Infrastructure Development Corporation, C-178/113 Moti Villa, Daudpur, Gorakhpur- 273001
Date of Approval of Building Plan & Site Plan:	10.06.2015
Date of Completion of the Building:	10.03.2017
Date of Inspection of the Building:	28.12.2018
Room Nos.	116 to 122 and 216-222
Area of Each Room:	122 Sqm.

It is further certified that the above referred building has been constructed as per Govt. regulations and norms. Relevant documents in support of the above claims are enclosed herewith as proof.


(Chandra Prakash Priyadarshi)
Registrar

NOTED: WATER SUPPLY
AND SANITARY FACILITIES
TO BE PROVIDED BY THE
BORAKHUR.

SECTION A-A

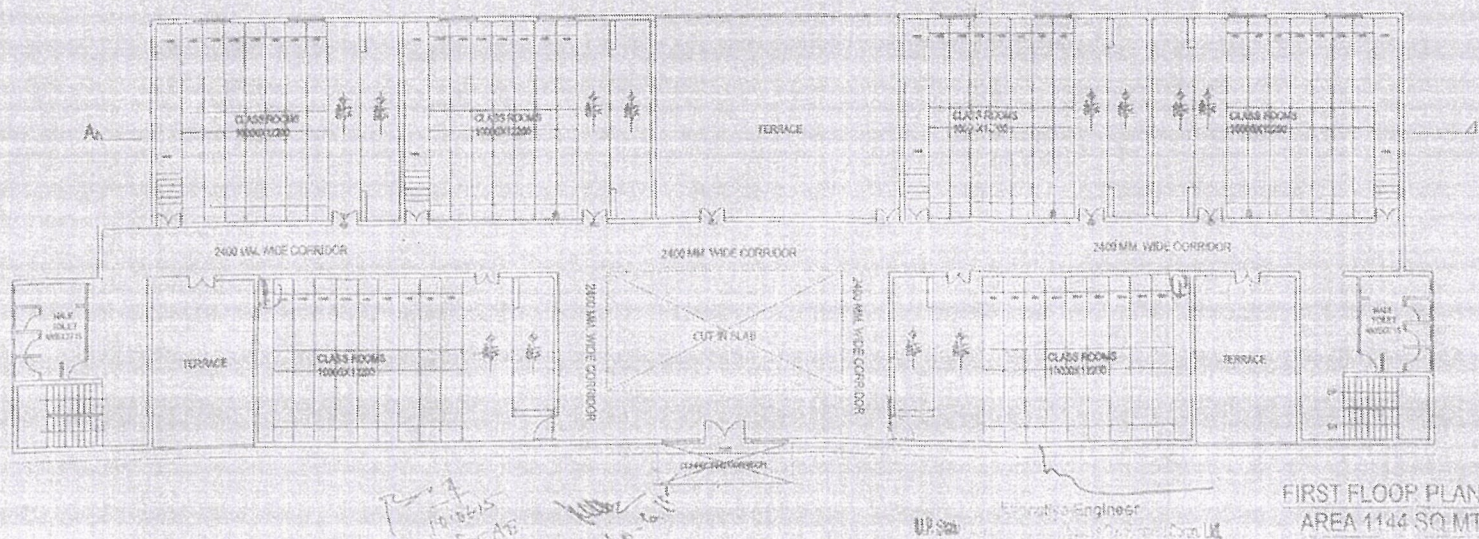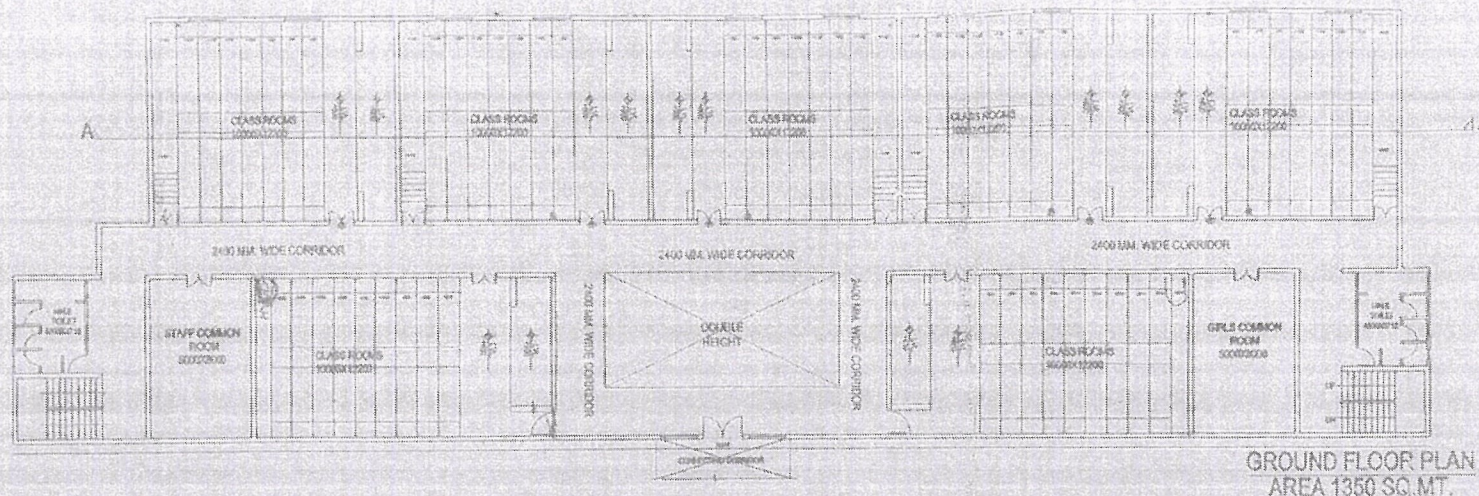


THIS DRAWING IS THE PROPERTY OF
U.P. STATE CONSTRUCTION &
INFRASTRUCTURE DEVELOPMENT
CORPORATION LTD. THIS IS NOT TO
BE REPRODUCED OR USED FOR ANY
OTHER PROJECTS WITHOUT THE
PERMISSION OF THE ARCHITECT

U.P. STATE CONSTRUCTION &
INFRASTRUCTURE
DEVELOPMENT
CORPORATION LTD.

Job Title
NEW LECTURE COMPLEX

Drawing Title
FLOOR PLAN

 Dwg. No. AR-01
Scale: N.T.S.
Date: MAY 2015
Drawn By:



Architect
RAJIVA KUMAR
ASSOCIATES
BAR VISHVI KHAN, GOMTI, VADGA
LUCKNOW

10.06.15
for AB

Registrar
M.M. University of Technology
Gorakhpur - 273010

UP
Enrollment No. 123456
Date 10.06.15

Registrar
Madan Mohan Malaviya University of Technology
Gorakhpur - 273010 (U.P.)

Signature

RAJIVA KUMAR ASSOCIATES
Architect P. H. No. 27/1553, 56
B-16, WILSON ROAD, NORTH JAGAR
(JAGAR)

Drawn By: _____
Date: 20/10/2018
Scale: 1/8" = 1'-0"
Dwg. No.: _____
Issued To: _____

Working Title: _____
GROUND FLOOR
WORKING PLAN

Job Title: _____
PROPOSED CLASS ROOMS
COMPLEX

Construction Agency: _____
U.P.S.C.D.C.L.D.

Revision	Description


THIS DRAWING IS THE PROPERTY OF RAJIVA KUMAR ASSOCIATES AND IS NOT TO BE REPRODUCED OR COPIED FOR ANY OTHER PROJECTS WITHOUT THE EXPRESS WRITTEN PERMISSION OF THE ARCHITECT.

WORKING DRAWING

PROPOSED EXTENSIONAL
BUILDING OF TECHNICAL
SCHOOL

LENO	NO	SIL	HEIGHT	WIDTH
D	2	P.L.	2550	2000
D1	14	P.L.	2550	1500
D2	3	P.L.	2550	900
D3	5	P.L.	2100	750
D4	2	P.L.	2100	1500
D5	11	P.L.	200	1800
D6	11	P.L.	450	600

GROUND FLOOR
DOOR WINDOW DETAIL FOR

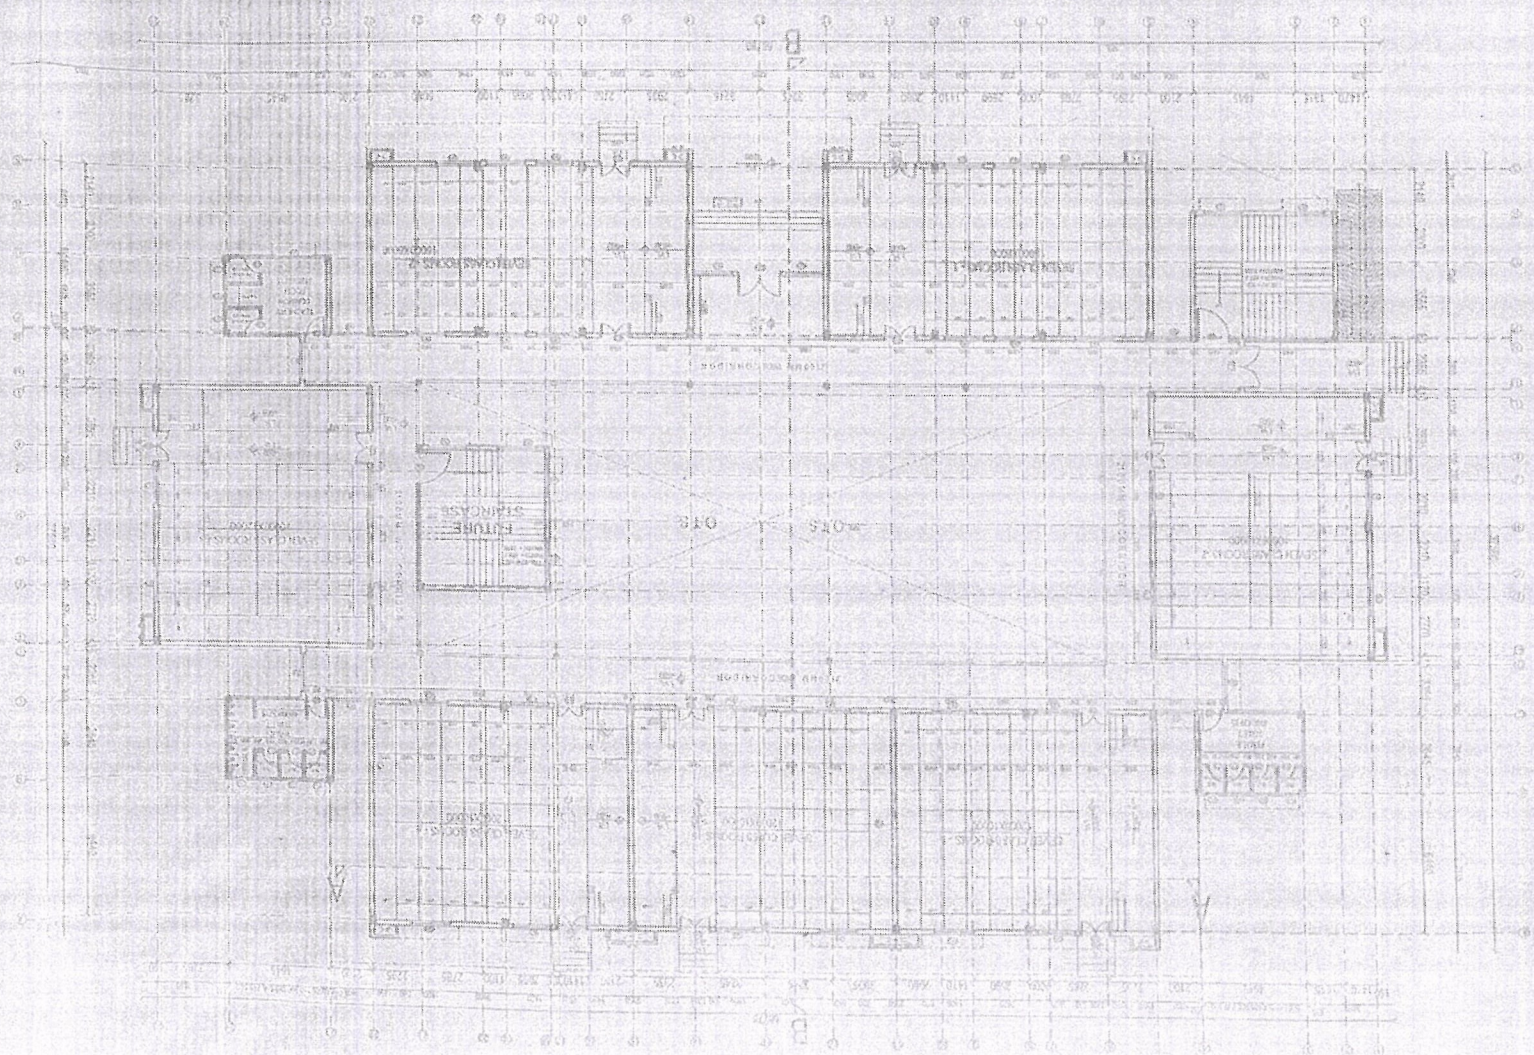

Registrar

Madan Mohan Malaviya University of Technology
Gorakhpur - 273010 (U.P.)

(Signature)

WORKSHOP
GATE

EXISTING
WORKSHOP

PROPOSED
LECTURE HALL
BUILDING

RAMP UP

PROPOSED CORRIDOR

EXISTING
LECTURE HALL
BUILDING

EXISTING
DEPT.

EXISTING
E.C. DEPT.

PROPOSED EXTENSION AT
MADAN MOHAN MALVIYA
UNIVERSITY OF TECHNOLOGY
GORAKHPUR.

THIS DRAWING IS THE PROPERTY OF
RAJIVA KUMAR & ASSOCIATES AND
ISSUED FOR THE SPECIFIC PROJECT
MENTIONED THEREIN. THIS IS NOT TO
BE COPIED OR USED FOR OTHER
PROJECTS UNLESS EXPRESSLY
PERMITTED BY THE ARCHITECT.

Remarks

U.P. STATE CONSTRUCTION &
INFRASTRUCTURE
DEVELOPMENT
CORPORATION LTD.

Job Title

NEW LECTURE COMPLEX

Drawing Title

SITE PLAN

Org. No. AR-01

North

Scale N.T.S.

Date MAY. 2015

Drawn By



Extension Engineer
U.P. State Construction & Infrastructure Development Corp. Ltd.
Gorakhpur

Registrar
M. University of Technology
Gorakhpur (U.P.)

Architect


PH. No.
272155554

RAJIVA KUMAR

&
ASSOCIATES

Registrar

Madan Mohan Malaviya University of Technology
Gorakhpur - 273010 (U.P.)

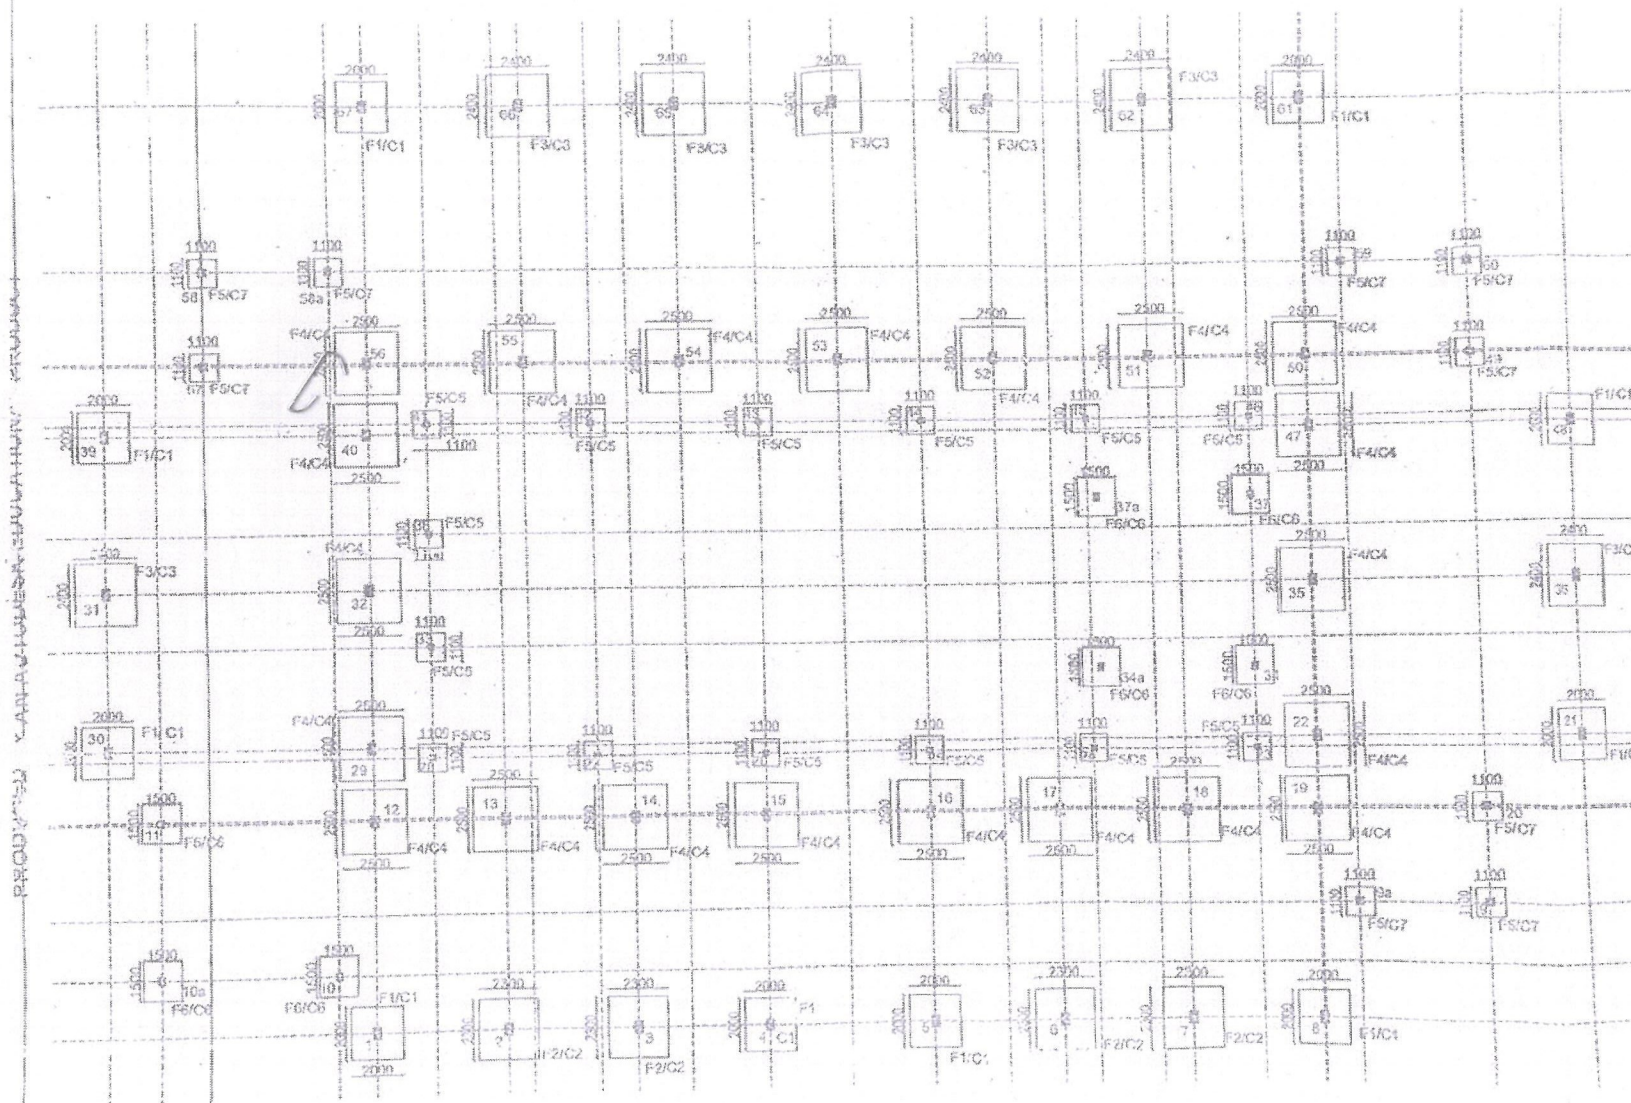

FOUNDATION & COLOUMN PLAN

PROJECT:

PROPOSED CLASS ROOM
AT
MADAN MOHAN MALVIYA
TECHNICAL UNIVERSITY
GORAKHPUR

NO. DATE

BUILDING:

Architect

Ph. No.
2721555, 56

RAJIVA KUMAR

ASSOCIATES

STRUCTURAL
CONSULTANTS:

STRUCTURAL CONSULTANTS
SANA PALACE, 5, SHARDAJEE ROAD
HAZRATGAU, LUCKNOW
VAT 10200224, MOH. 052255

DESIGN

DESIGN TITLE
FOUNDATION & COLOUMN
PLAN

DATE

DATE


DATE

DATE

DATE

DATE

Registrar
Madan Mohan Malaviya University of Technology
Gorakhpur - 273010 (U.P.)

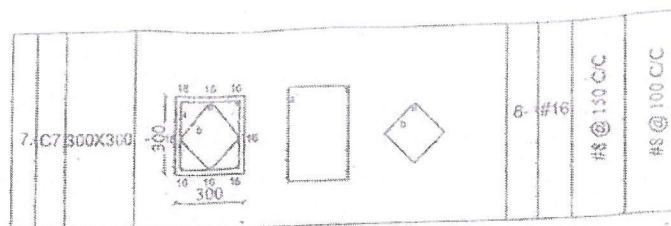[illegible][illegible]

FOOTING REINFORCEMENT DETAIL.

FOOTING GROUP	P.C.C. SIZE	FOOTING (BxL)	D	D1	REINF. PARALLEL TO X- AXIS	REINF. PARALLEL TO Y- AXIS
F1	2000X2000	1900X1900	200	700	#10@150C/C	#10@150C/C
F2	2300X2300	2200X2200	200	750	#10@150C/C	#10@150C/C
F3	2400X2400	2300X2300	200	800	#10@125C/C	#10@125C/C
F4	2550X2550	2450X2450	200	800	#10@125C/C	#10@125C/C
F5	1100X1100	1000X1000	150	600	#8@150C/C	#8@150C/C
FF	1500X1500	1400X1400	150	650	#8@150C/C	#8@150C/C

PROJECT :			
PROPOSED CLASS ROOM AT MADAN MOHAN MALVIYA TECHNICAL UNIVERSITY GORAKHPUR			
NO.	DATE	REVISION	AFTER
BUILDING:			
Architect		Ph. No. 2721555, 56	
			
STRUCTURAL CONSULTANTS :		TASCOR CONSULTANTS	
		SANA PALACE, 3, SHAHNAJAF ROAD, HAZRATGANJ, LUCKNOW MOB. 09538002256, (0522) - 4864189	
DESIGN Capt Mangy Waman (Retd) DIRECTOR ARMY INSTITUTE OF ARCHITECTURE AGRA (INDIA)		DRG TITLE FOUNDATION & COLUMN- BED REINFORCEMENT DETAIL	
DRAWN Capt Mangy Waman (Retd) PRINCIPAL ARCHITECT, TASCOR CONSULTANTS LUCKNOW	Am Thawat	SCALE	DRG NO.
CHECKED Capt Mangy Waman (Retd) PRINCIPAL ARCHITECT, TASCOR CONSULTANTS LUCKNOW	25/12/14	NT.S	0

PRODUCED BY AN AUTODESK EDUCATIONAL PRODUCT

Registrar
Madan Mohan Malaviya University of Technology
Gorakhpur - 273010 (U.P.)

PRODUCED BY AN AUTOMATIC EDUCATIONAL PRODUCT

मदन मोहन मालवीय प्रौद्योगिकी विश्वविद्यालय, गोरखपुर में सम्पादित कराये जा रहे कार्यो की वित्तीय प्रगति
कार्यदायी संस्था- यू0पी0स्टेट कांस्ट्रक्शन एण्ड इन्फ्रास्ट्रक्चर डेवलपमेन्ट कारपोरेशन लि0
शासन द्वारा सीधे कार्यदायी संस्था को आवंटित कार्य

माह :- ~~दिसम्बर~~ -2018

(धनराशि रुपये लाख में)

क्र.सं.	कार्य का नाम	स्वीकृत लागत	पुनरीक्षित स्वीकृत लागत	शासन द्वारा अवमुक्त धनराशि	इकाई को प्राप्त धनराशि	व्यय धनराशि	प्राप्त की जाने वाली अवशेष धनराशि (5-6)	टिप्पणी
1	2	3	4	5	6	7	8	9
1	75क्षमता गर्ल्स छात्रावास का निर्माण ।	361.33	449.26	449.26	426.846	385.21	22.415	हस्तांतरित 10.03.2017
2	इलेक्ट्रानिक्स एण्ड कम्युनिकेशन विभाग में सेमिनार रूम एवं लैब का निर्माण।	63.32	63.32	63.32	60.155	67.17	3.165	हस्तांतरित 10.03.2017
3	मैकेनिकल इंजीनियरिंग विभाग में लेबोरेटरी तथा सेमिनार रूम का निर्माण।	54.02	70.82	70.82	67.275	72.22	3.545	हस्तांतरित 10.03.2017
4	कम्प्यूटर साइंस विभाग में लेबोरेटरी तथा सेमिनार रूम का निर्माण।	62.90	62.90	62.90	59.755	60.60	3.145	हस्तांतरित 10.03.2017
5	एप्लाइड साइंस विभाग में लेबोरेटरी तथा सेमिनार रूम का निर्माण।	51.63	60.73	60.73	57.695	58.23	3.035	हस्तांतरित 10.03.2017
6	इलेक्ट्रिकल इंजीनियरिंग विभाग में लेबोरेटरी तथा सेमिनार रूम का निर्माण।	60.31	60.31	60.31	57.295	61.565	3.015	हस्तांतरित 10.03.2017
7	सिविल इंजीनियरिंग विभाग में लेबोरेटरी तथा सेमिनार रूम का निर्माण।	65.48	78.03	78.03	74.13	78.97	3.90	हस्तांतरित 10.03.2017
8	07 नग क्लास रूम भवन का निर्माण कार्य।	307.08	367.47	367.47	349.095	299.84	18.375	हस्तांतरित 10.03.2017
9	मल्टी परपज हाल में रिनोवेशन कार्य।	60.08	77.43	77.43	73.560	75.46	3.870	हस्तांतरित 10.03.2017
10	लाइब्रेरी हाल में वातानुकूलन का कार्य।	24.21	24.21	24.21	10.71	10.39	13.50	हस्तांतरित 10.03.2017
11	20 क्लास रूम / सुगर टेक्नोलॉजी।	912.48	1194.07	1194.07	1134.3665	994.42	59.7035	13 क्लास रूम दि0 10.03.2017 को हस्तांतरित अन्य 07 नग प्रगति पर
12	240 क्षमता छात्र-छात्रावास	835.30	947.43	947.43	863.90	864.89	83.53	कार्य पूर्ण इन्वेन्ट्री प्रेषित
13	मदन मोहन मालवीय में चहारदीवारी का कार्य ।	522.79	794.18	794.18	754.76	780.52	39.42	कार्य पूर्ण इन्वेन्ट्री प्रेषित
14	2000क्षमता आडिटोरियम भवन का निर्माण ।	917.16	1488.27	1488.27	883.242	870.72	605.028	प्रगति पर
15	एम0पी0हाल वातानुकूल कार्य।	30.12	30.12	30.12	30.12	27.37	-----	प्रगति पर
16	रूसा के अन्तर्गत प्रयुक्त विज्ञान विभाग, जनपदीय अभियन्त्रण विभाग, यांत्रिक अभियन्त्रण विभाग, विद्युत अभियन्त्रण विभाग, एवं विद्युतकरण एवं संचार अभियन्त्रण विभाग से प्रथम तल पर प्रयोगशाला के विस्तार / उच्चीकरण का कार्य।	170.50	170.50	170.50	127.875	27.50	42.625	कार्य पूर्ण दि0
	योग-	4498.71	5939.05	5939.05	5030.779	4735.175	908.2715	

Registrar
Madan Mohan Malaviya University of Technology
Gorakhpur - 273010 (U.P.)

अधिसासी अभियन्ता
यू0पी0सिडको, गोरखपुर